


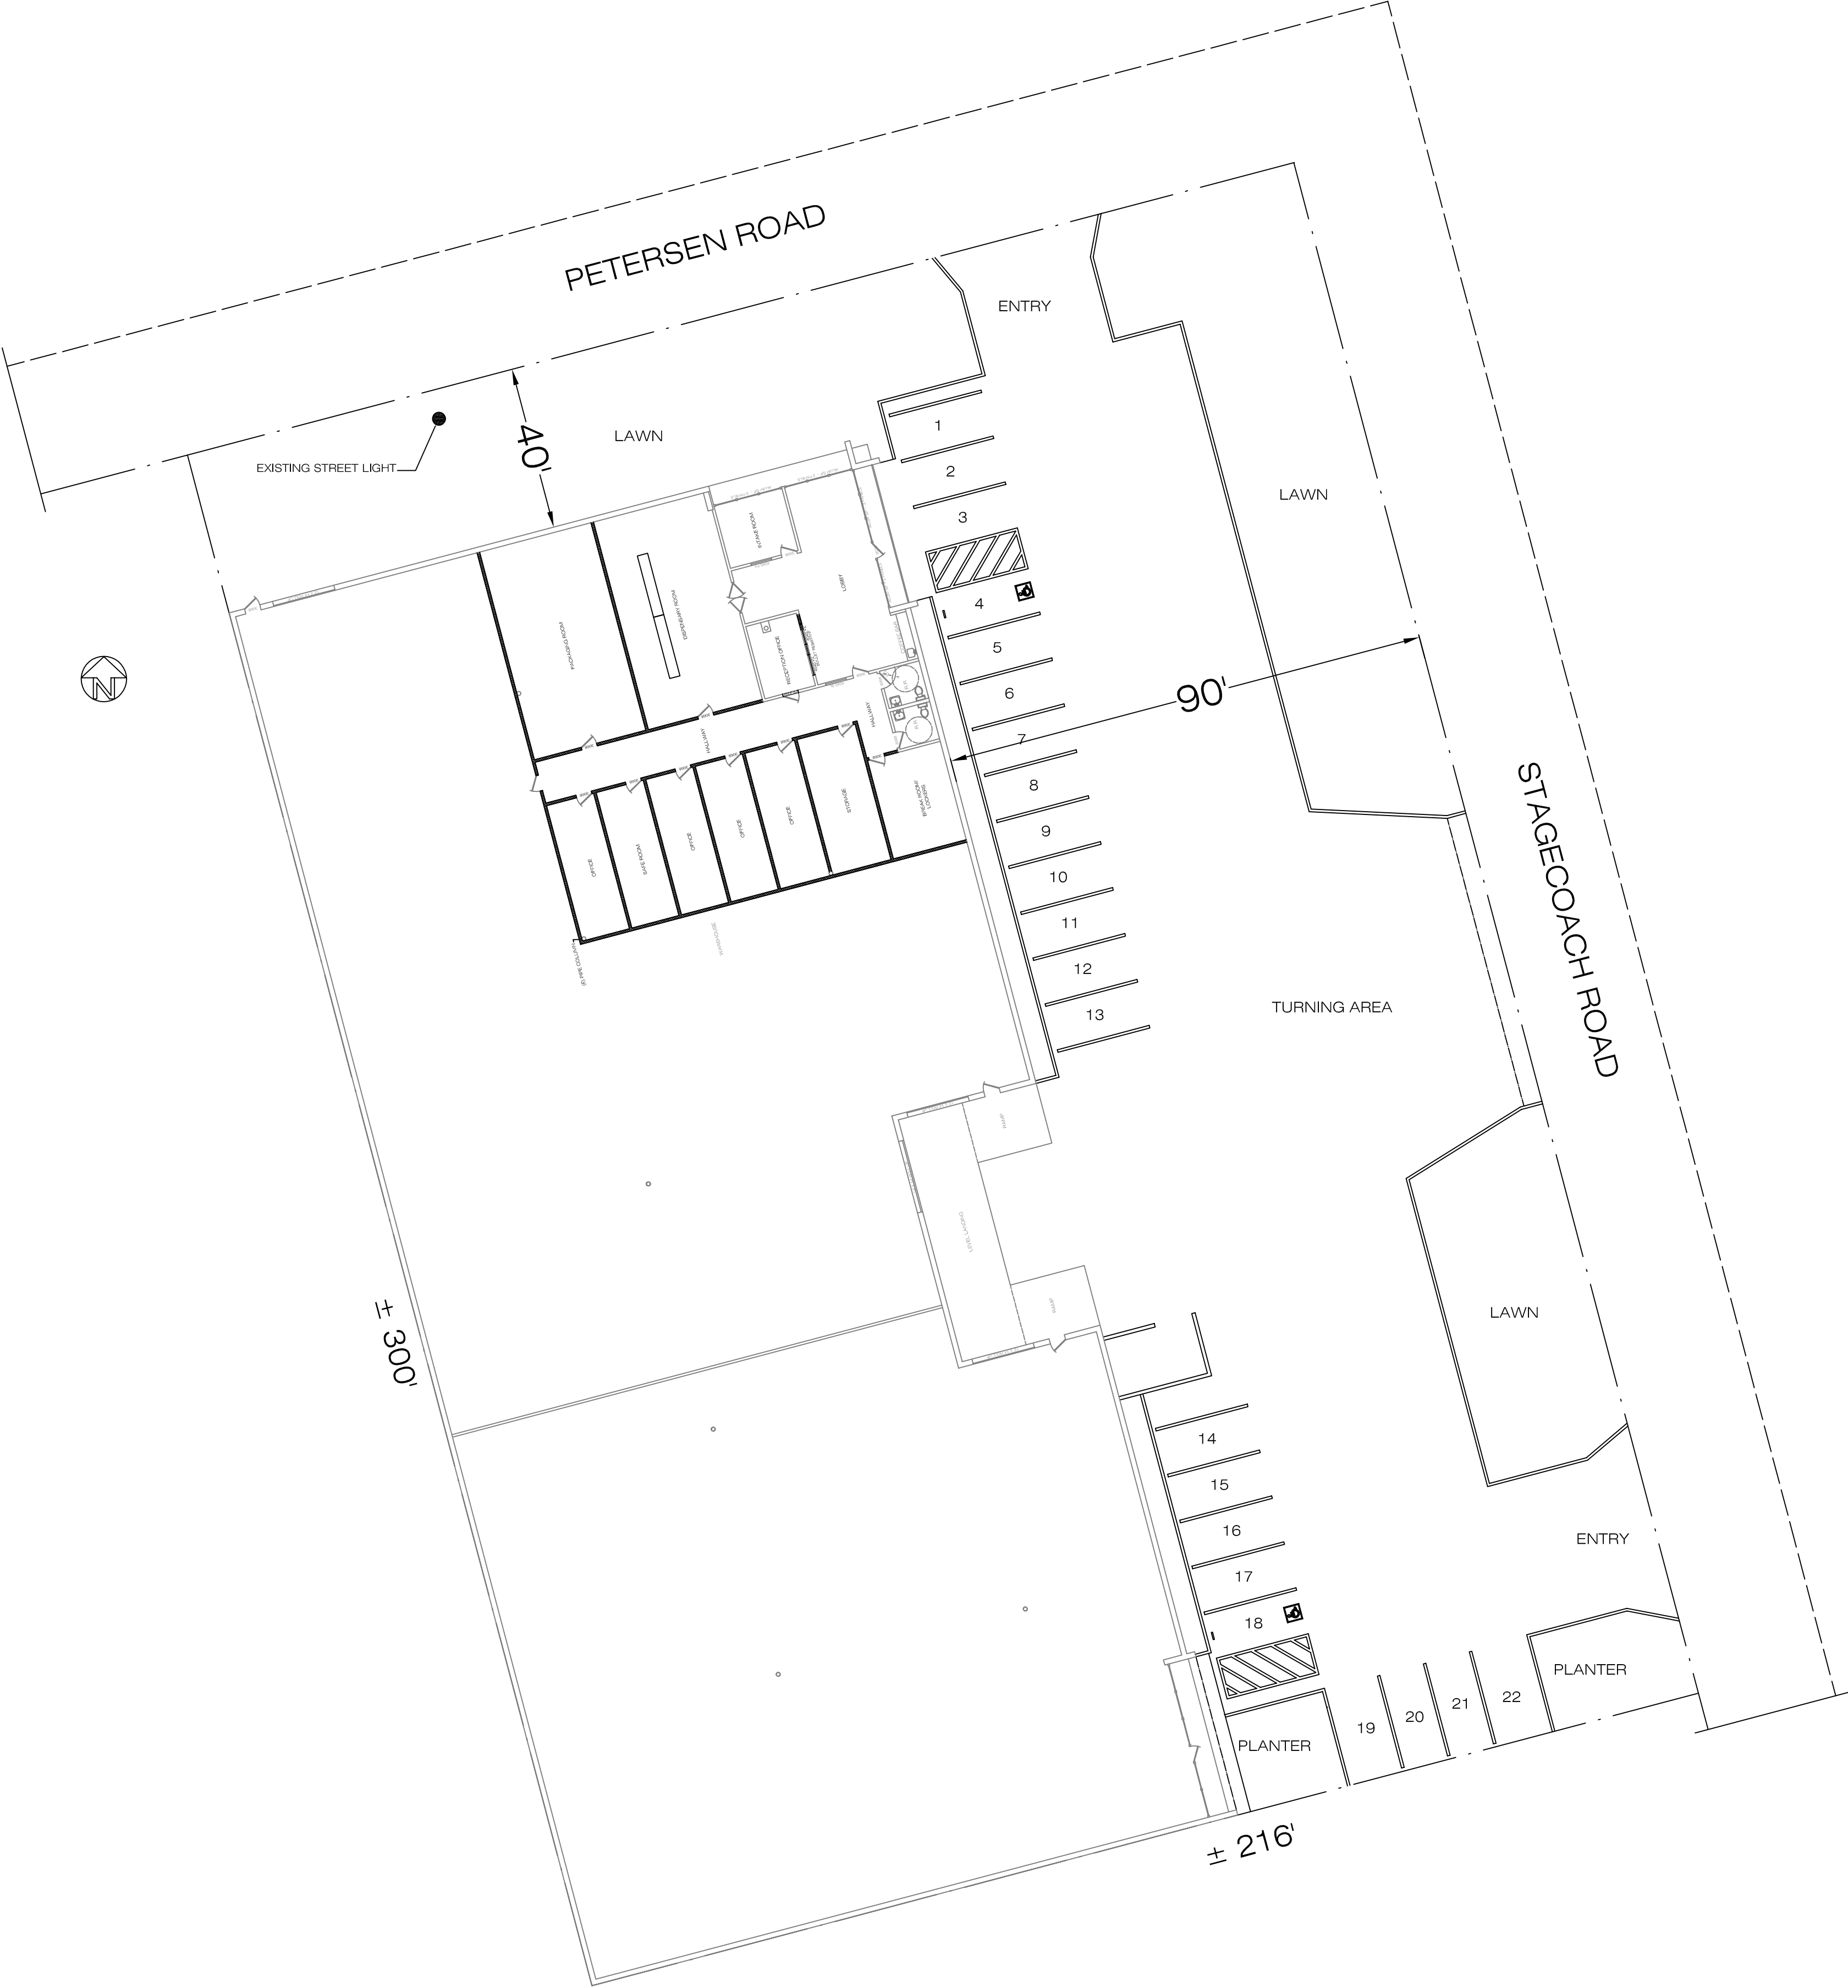


DRAWN BY:	VEE	DATE	DESCRIPTION	DATE	DESCRIPTION
DATE:	2-17-17				
PROJECT NO.					
SCALE:	1" = 20'-0"				

Dispensary
2403 Stagecoach Road
Stockton, CA

Valerie Ehrke Design
306 5th Street
P.O. Box 1444
Arbuckle, CA 95912
(530) 681-1218

DRAWING INDEX	
A-1.0	COVER SHEET
A-2.1	SITE PLAN
A-2.2	EXISTING FLOOR PLAN
A-2.3	PROPOSED FLOOR PLAN
A-2.4	PROPOSED SECURITY PLAN
A-2.5	DETAILS
A-2.6	SITE ILLUMINATION PLAN

SHEET NO.
A2.1

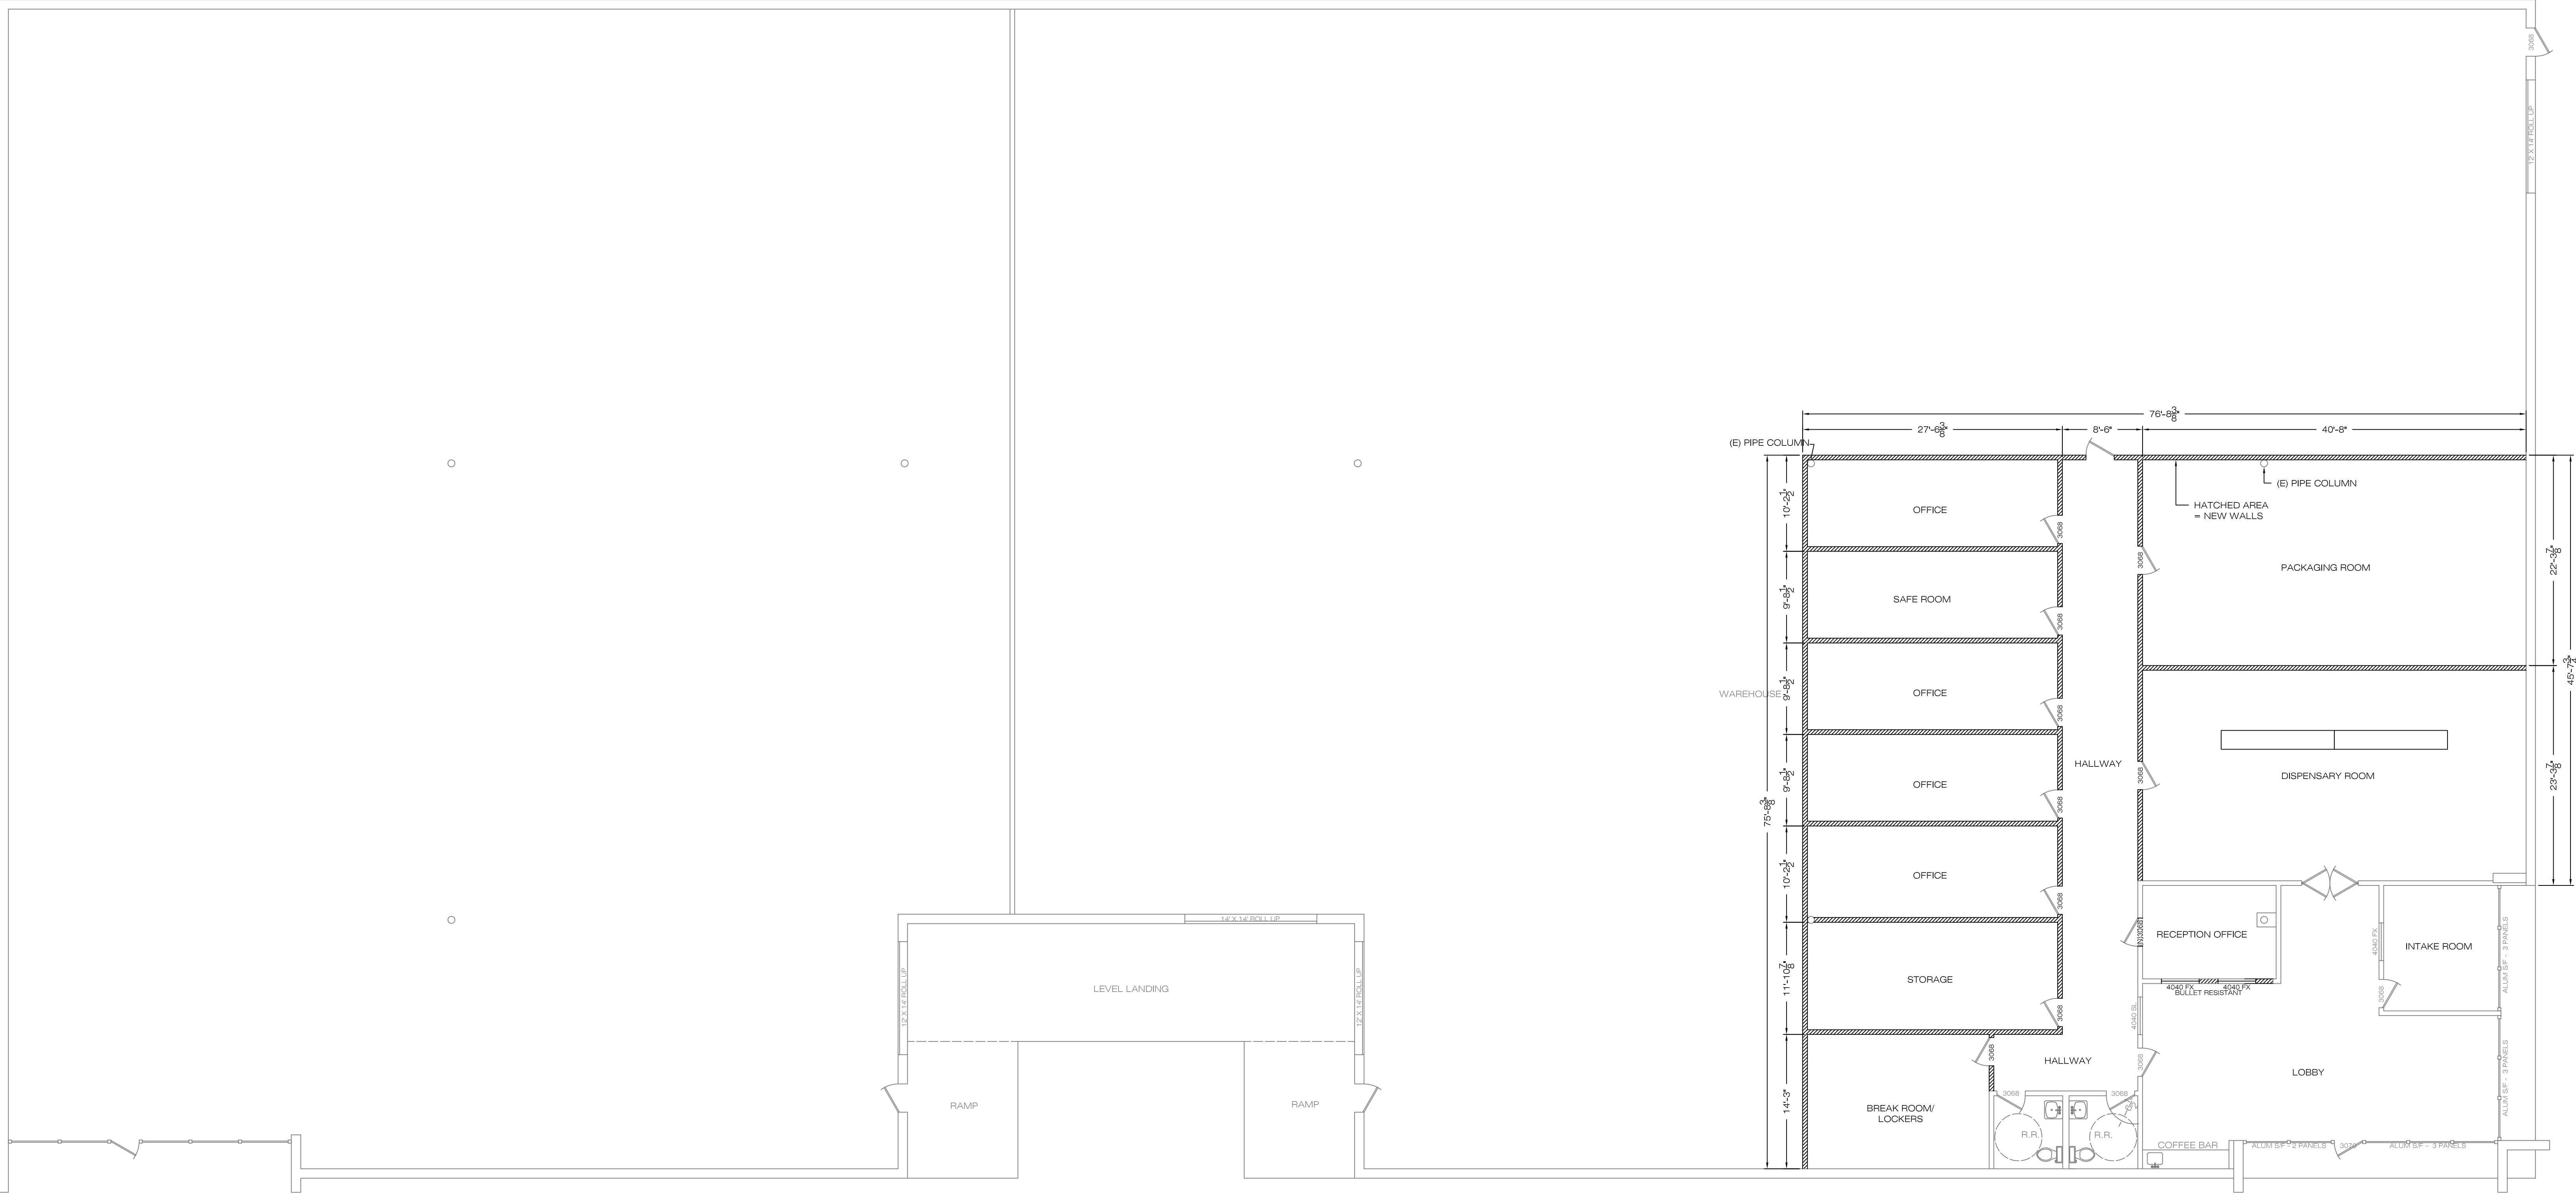

DRAWN BY:	VEE	DATE	DESCRIPTION	DATE	DESCRIPTION
DATE:	2-17-17		Δ		
PROJECT NO.					
SCALE:					

Dispensary
2403 Stagecoach Road
Stockton, CA

Valerie Ehrke Design
306 5th Street
P.O. Box 1444
Arbuckle, CA 95912
(530) 681-1218

DRAWING INDEX	
A-1.0	COVER SHEET
A-2.0	SITE PLAN
A-3.0	EXISTING FLOOR PLAN
A-4.0	PROPOSED FLOOR PLAN
A-5.0	PROPOSED SECURITY PLAN
A-6.0	DETAILS

SHEET NO.
A2.3