


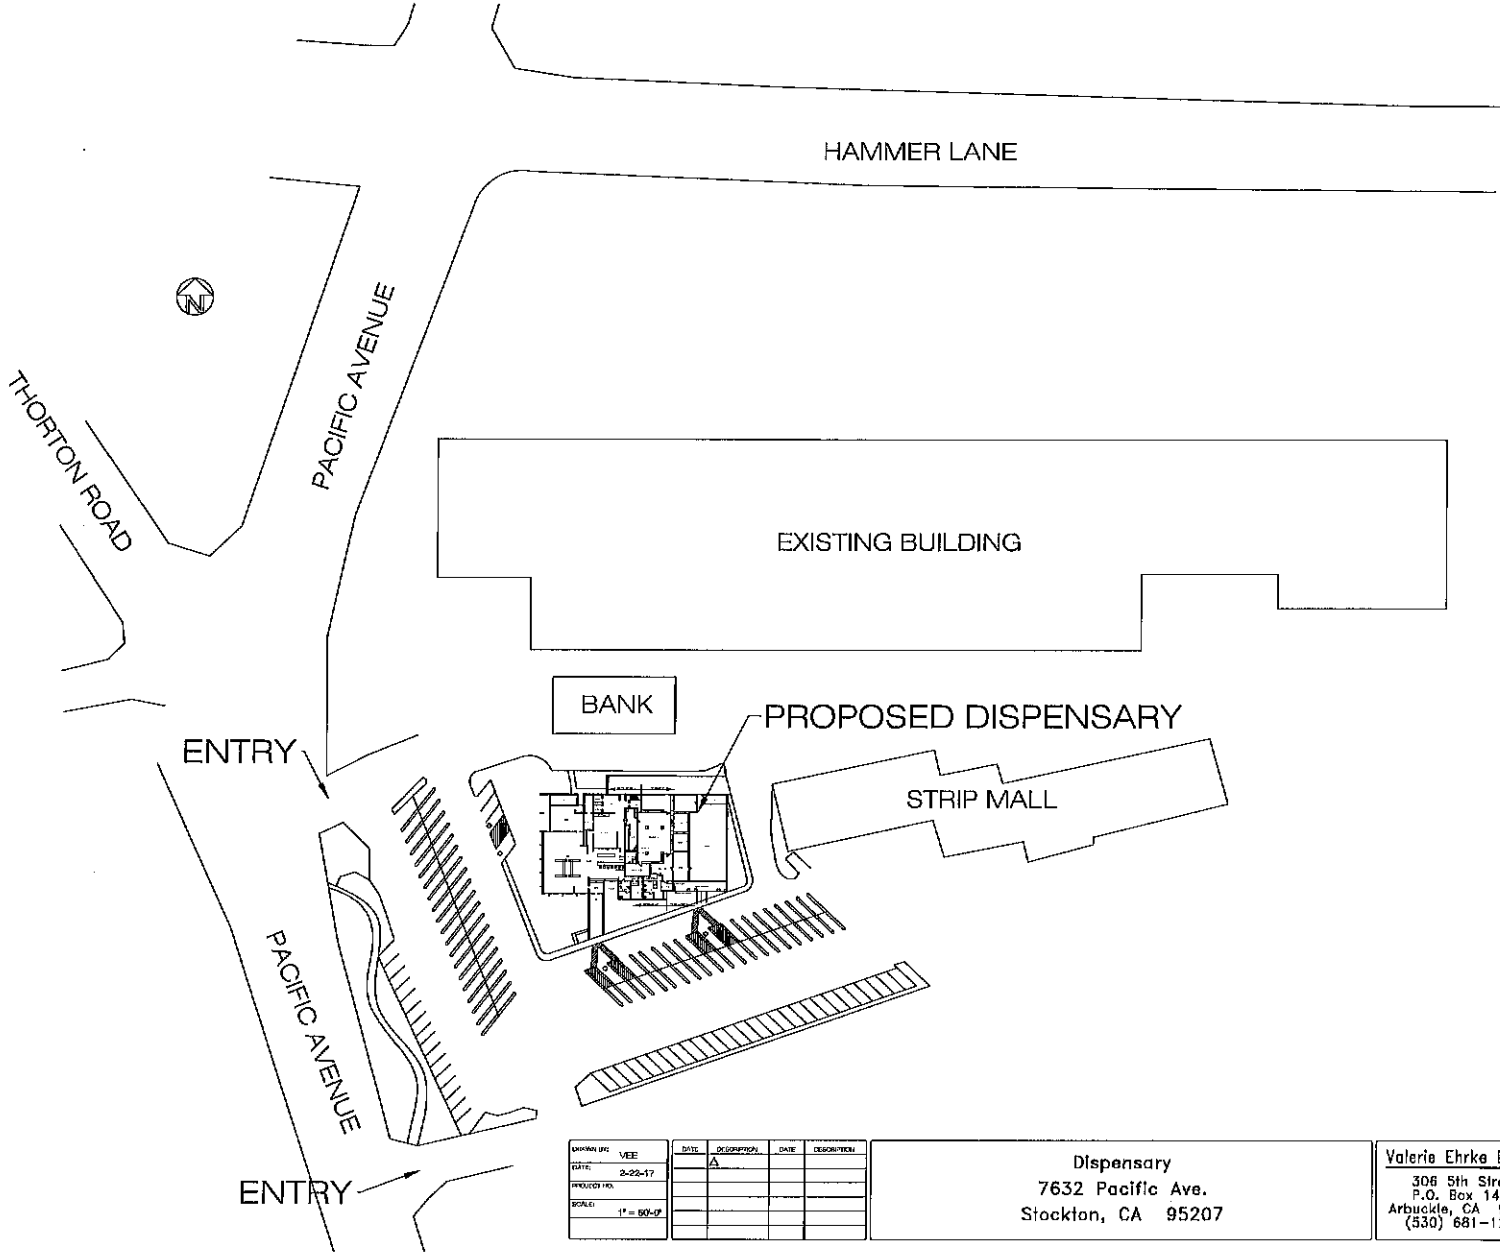


DESIGNED BY	VEE	DATE	DESCRIPTION	DATE	DESCRIPTION
DRAWN BY	VEE	DATE	DESCRIPTION	DATE	DESCRIPTION
DATE	2-25-17				
PROJECT NO.					
SCALE	1" = 50'-0"				

Dispensary
7632 Pacific Ave.
Stockton, CA 95207

Valerie Ehrke Design
306 5th Street
P.O. Box 1444
Arbuckle, CA 95912
(530) 681-1218

DRAWING INDEX		SHEET NO.
A-2.1	SITE PLAN	
A-2.2	EXISTING FLOOR PLAN	A2.1
A-2.3	PROPOSED FLOOR PLAN	
A-2.4	ENCLOSURE SECURITY PLAN	

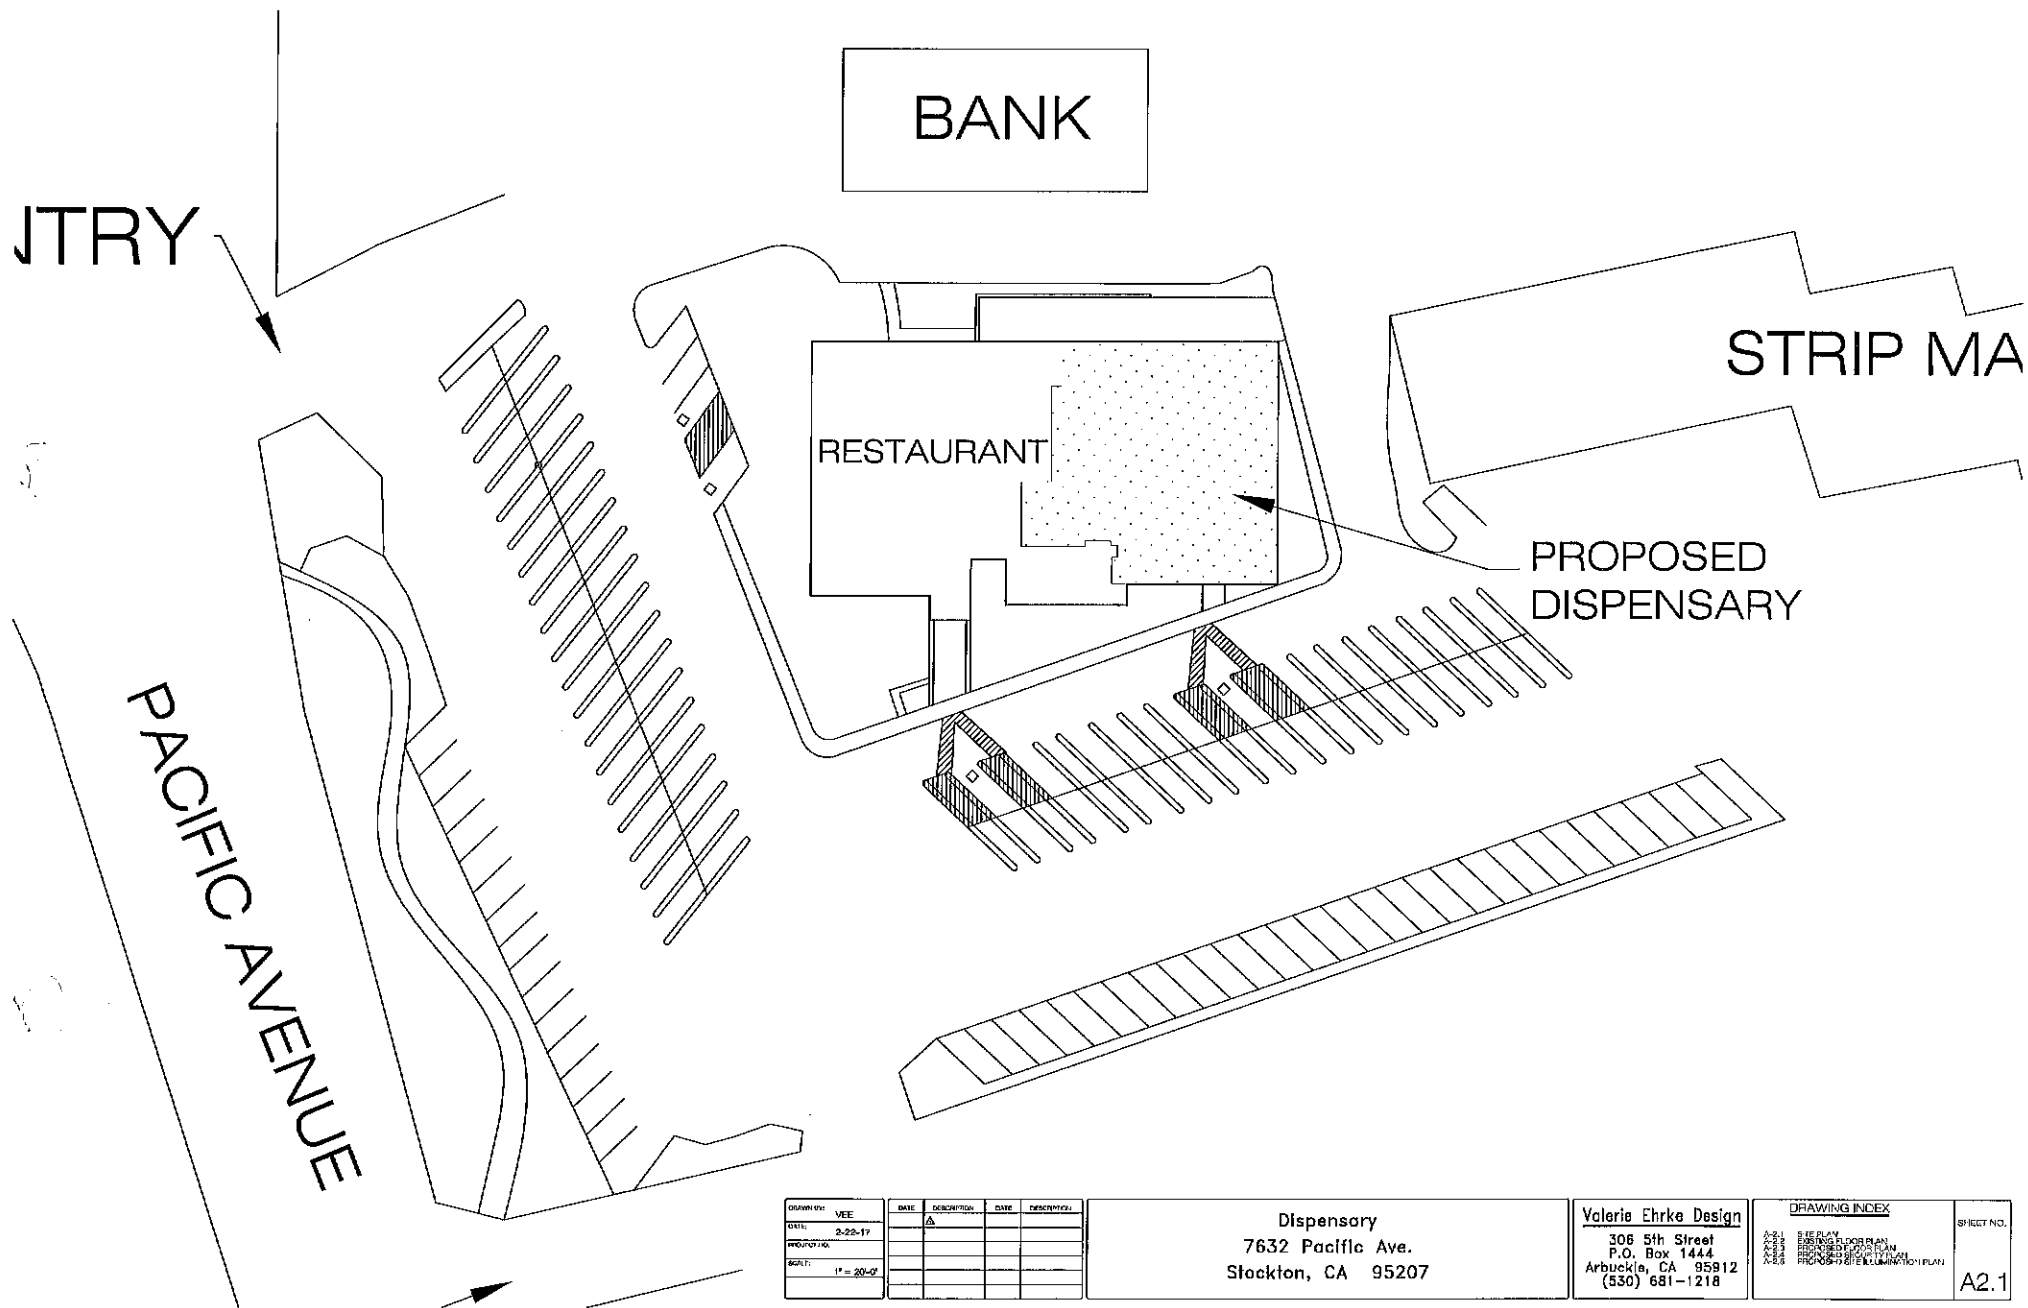

DESIGNED BY	VEE	DATE	DESCRIPTION	DATE	DESCRIPTION
DRAWN BY					
CHECKED BY					
PROJECT NO.					
SCALE	1" = 20'-0"				

Dispensary
7632 Pacific Ave.
Stockton, CA 95207


Valerie Ehrke Design
306 5th Street
P.O. Box 1444
Arbuckle, CA 95912
(530) 681-1218

DRAWING INDEX

A-2.1 SITE PLAN
A-2.2 EXISTING FLOOR PLAN
A-2.3 PROPOSED FLOOR PLAN
A-2.4 PROPOSED SITE LAYOUT
A-2.5 PROPOSED SITE ELEVATION PLAN

SHEET NO.

A2.1

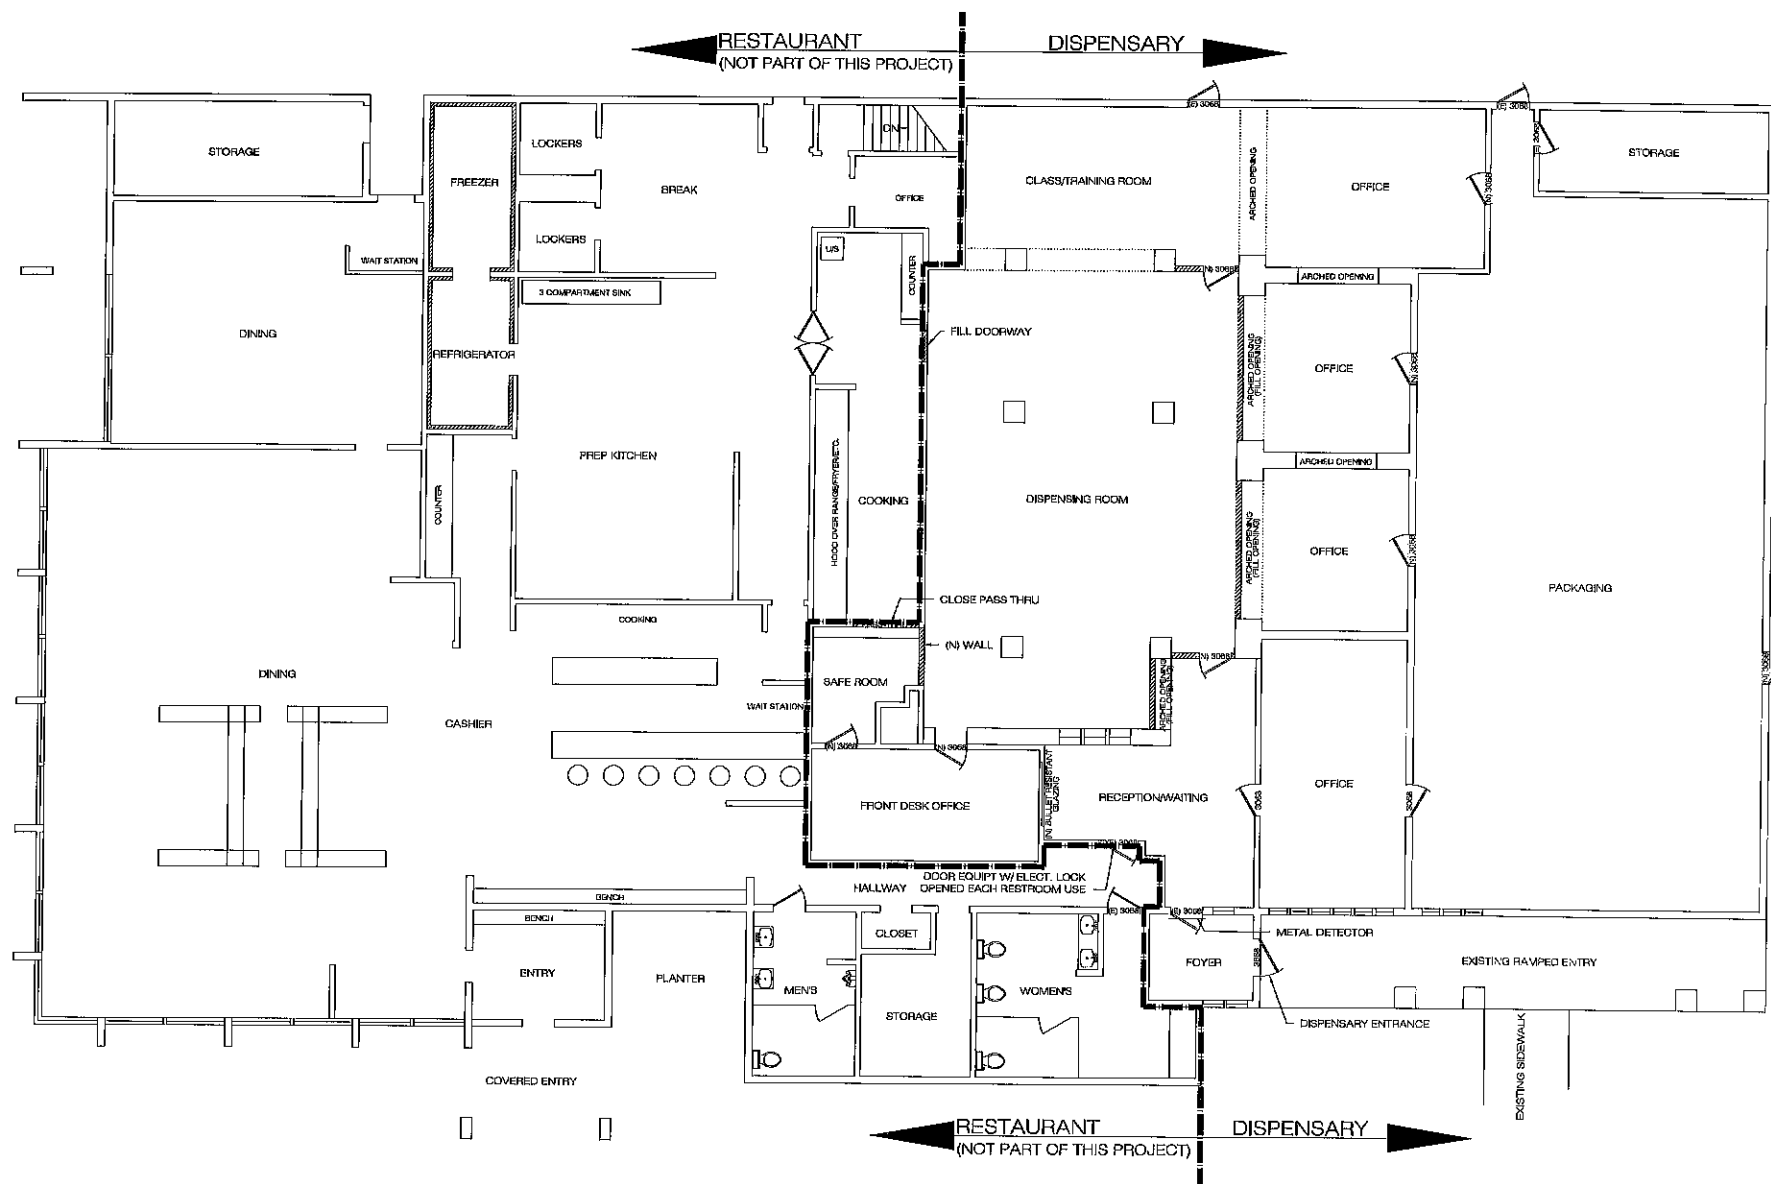

DESIGNED BY	VEE	DATE	2-22-17	PROJECT NO.		SCALE	3/16" = 1'-0"
DATE	2-22-17	DESCRIPTION		DATE		DESCRIPTION	

Dispensary
7632 Pacific Ave.
Stockton, CA 95207

Valerie Ehrke Design
306 5th Street
P.O. Box 1444
Arbuckle, CA 95912
(530) 681-1218

DRAWING INDEX	
A-2.1	SITE PLAN
A-2.2	EXISTING FLOOR PLAN
A-2.3	PROPOSED FLOOR PLAN
A-2.4	PROPOSED SECURITY PLAN
A-2.5	PROPOSED SITE ILLUMINATION PLAN

SHEET NO.
A2.3